

## CURB SIDE EXTERIOR ELEVATION

THIS DRAWING IS THE PROPERTY OF FRONTLINE COMMUNICATIONS. IT IS CONFIDENTIAL AND ALL RIGHTS ARE RESERVED. IT SHALL NOT BE REPRODUCED, COPIED, LENT, OR USED FOR ANY PURPOSE OTHER THAN THAT FOR WHICH IT IS SPECIFICALLY FURNISHED.

PRELIMINARY USE ONLY  
THIS DRAWING IS FOR REPRESENTATION ONLY. DETAILED ENGINEERING DRAWINGS WILL BE CREATED FOR MANUFACTURING. CHANGES MAY BE REQUIRED TO ACCOMMODATE MANUFACTURING REQUIREMENTS AND CUSTOMER SPECIFICATIONS.


DRAWN	J.Chriss	DATE	8-5-16
SHEET	1 OF 6	NOT TO SCALE	

**FRONTLINE COMMUNICATIONS**  
An Oshkosh Corporation Company

12770 44th Street North  
Clearwater, FL 33762  
Phone (727) 573-0400  
www.frontlinecomm.com

**OSHKOSH**

<b>COBB COUNTY FIRE &amp; EMERGENCY MCV - C-43X-4 - INTL 7600</b>		
SIZE	DWG NO.	REV
B	047422	-

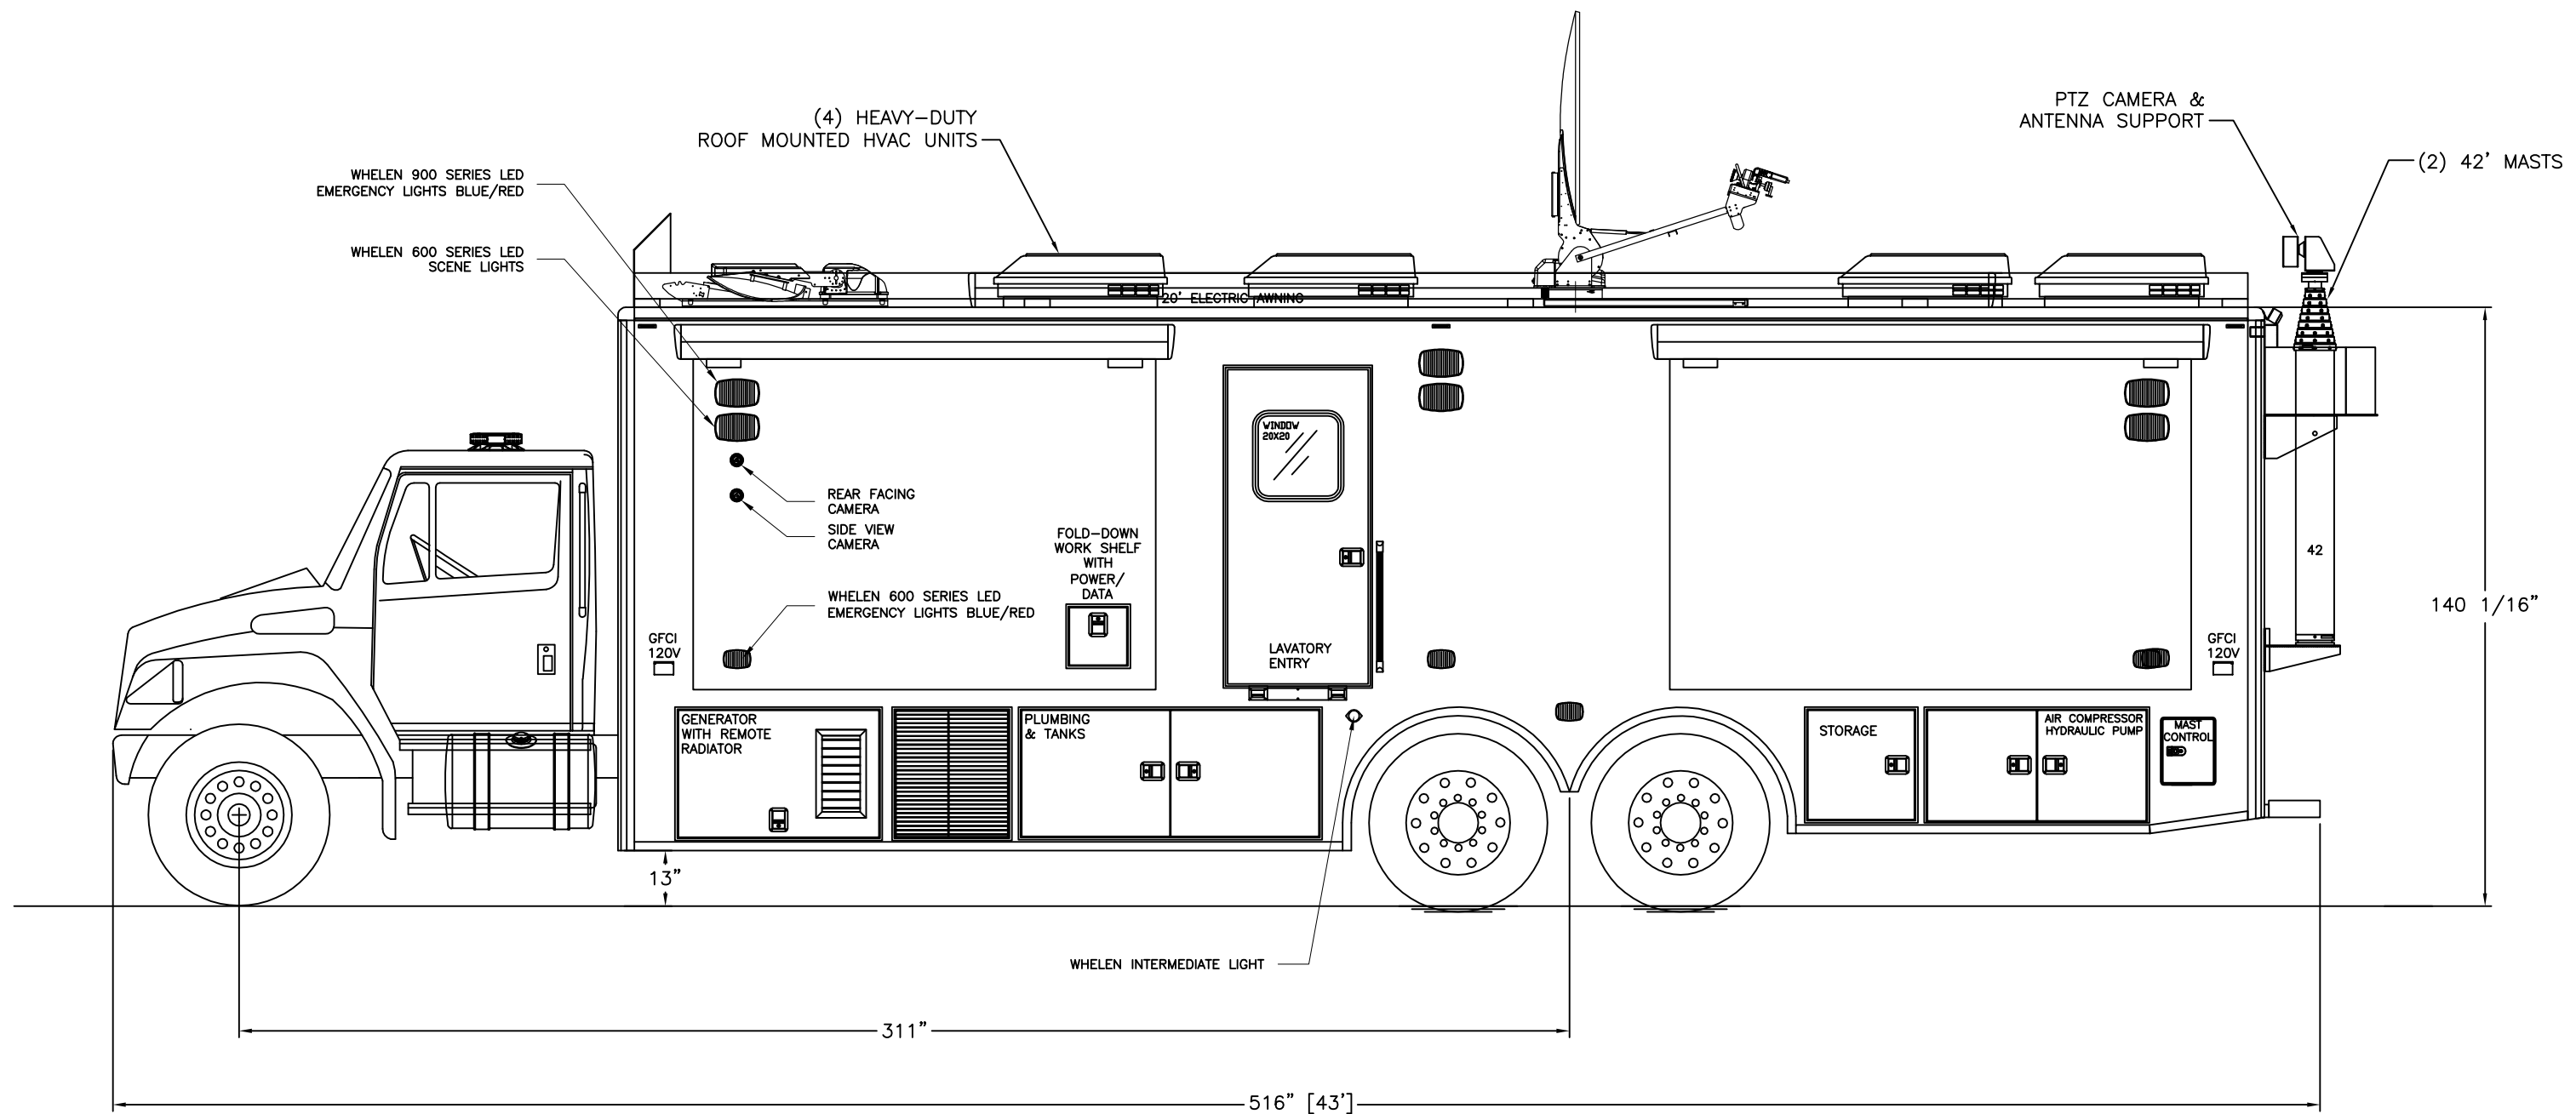

## STREET SIDE EXTERIOR ELEVATION

THIS DRAWING IS THE PROPERTY OF FRONTLINE COMMUNICATIONS. IT IS CONFIDENTIAL AND ALL RIGHTS ARE RESERVED. IT SHALL NOT BE REPRODUCED, COPIED, LENT, OR USED FOR ANY PURPOSE OTHER THAN THAT FOR WHICH IT IS SPECIFICALLY FURNISHED.


PRELIMINARY USE ONLY  
THIS DRAWING IS FOR REPRESENTATION ONLY. DETAILED ENGINEERING DRAWINGS WILL BE CREATED FOR MANUFACTURING. CHANGES MAY BE REQUIRED TO ACCOMMODATE MANUFACTURING REQUIREMENTS AND CUSTOMER SPECIFICATIONS.


DRAWN	J.Chriss	DATE	8-5-16
SHEET	2 OF 6	NOT TO SCALE	


**FRONTLINE COMMUNICATIONS**  
An Oshkosh Corporation Company  
12770 44th Street North  
Clearwater, FL 33762  
Phone (727) 573-0400  
www.frontlinecomm.com



<b>COBB COUNTY FIRE &amp; EMERGENCY MCV - C-43X-4 - INTL 7600</b>		
SIZE	DWG NO.	REV
<b>B</b>	<b>047422</b>	<b>-</b>

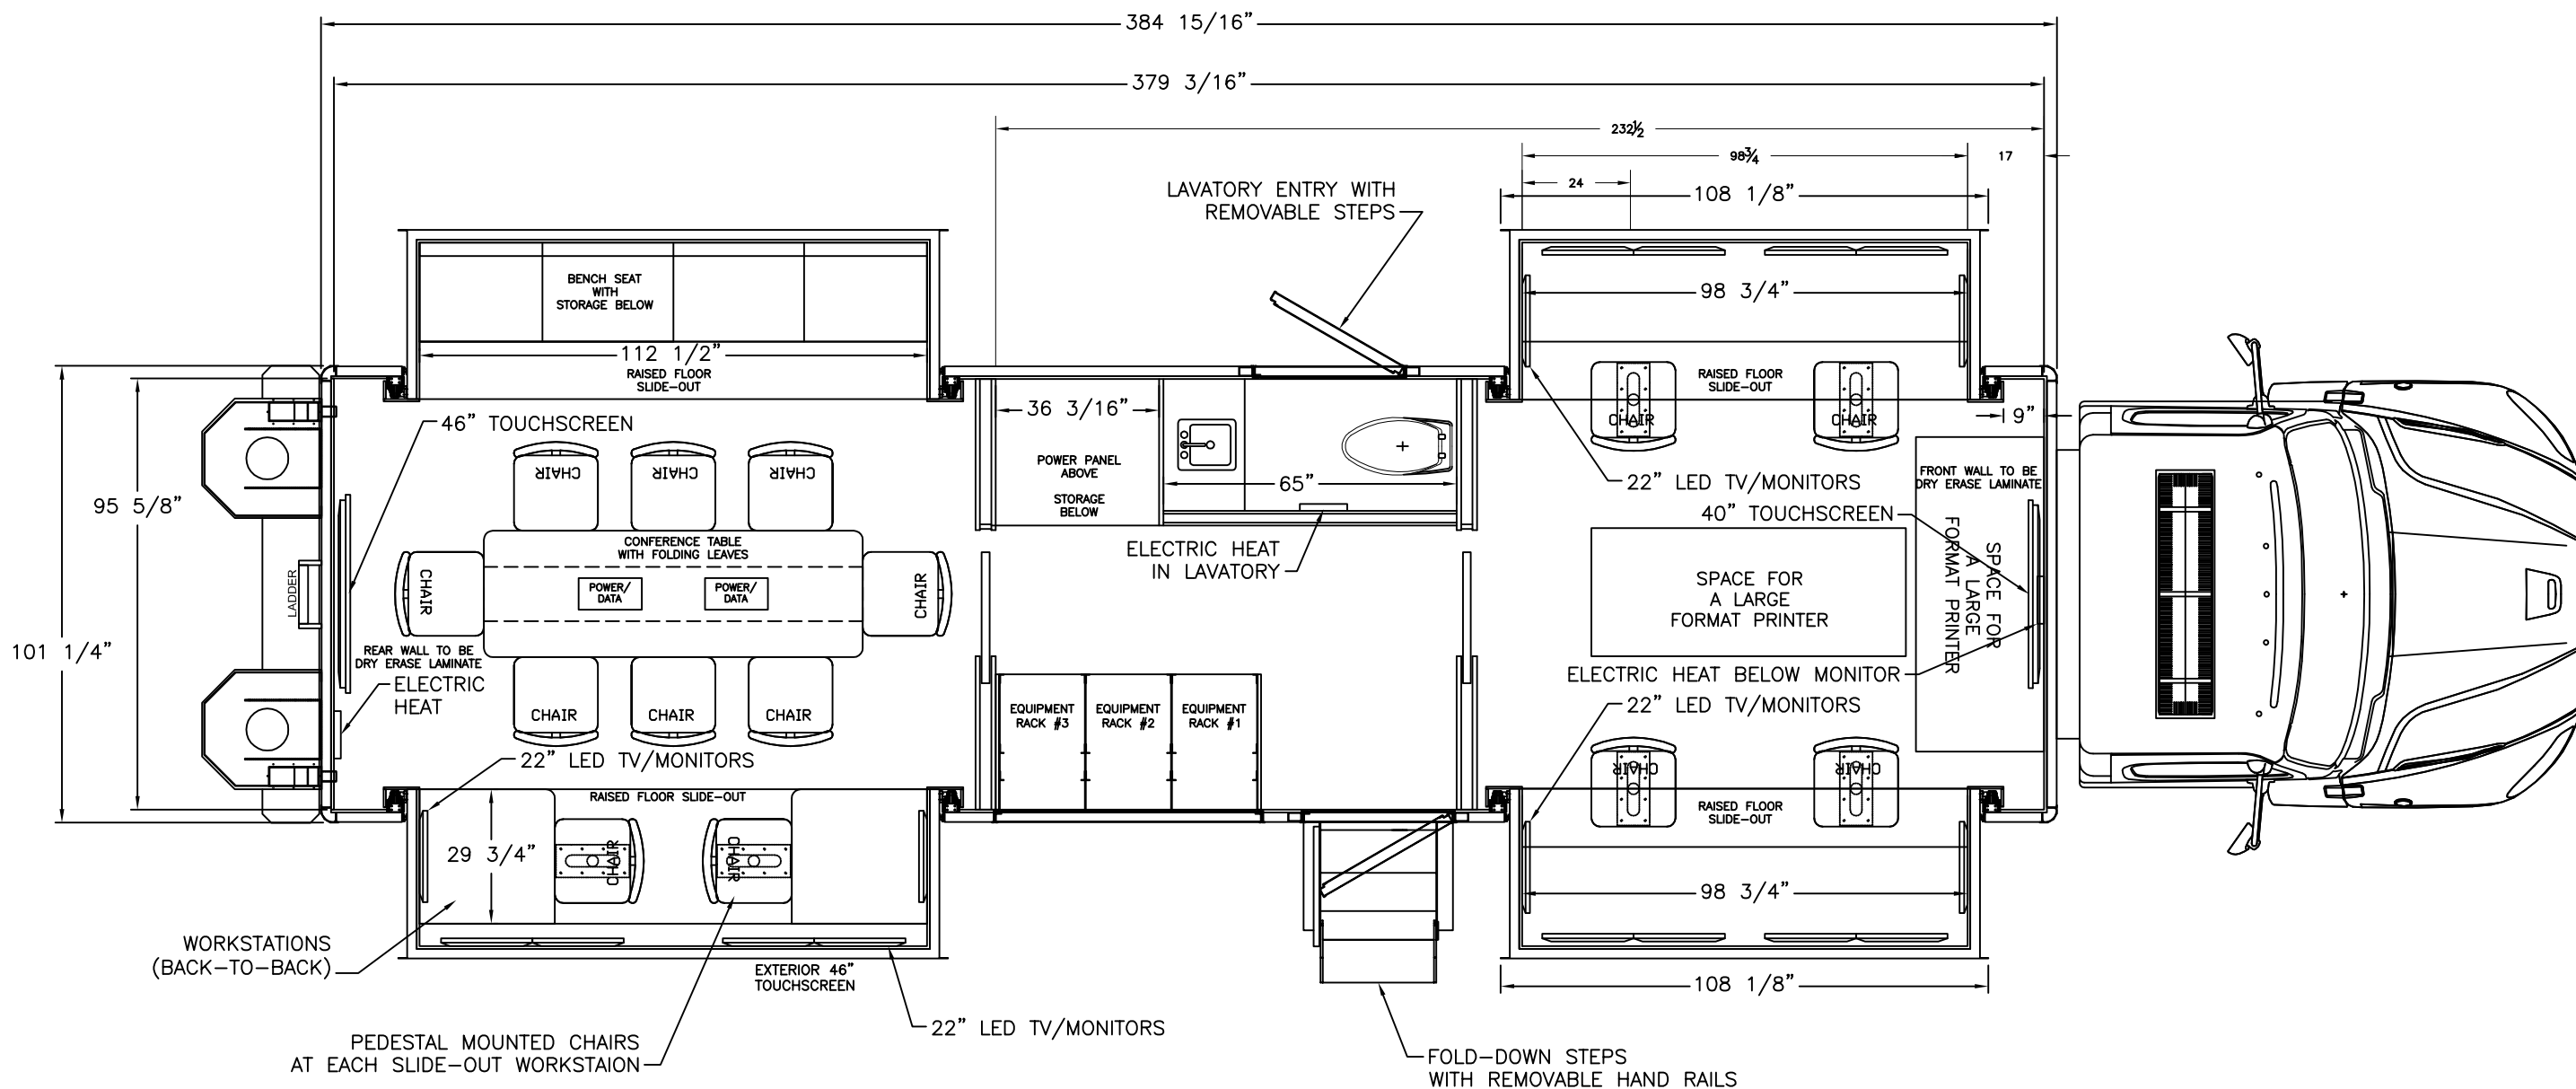


THIS DRAWING IS THE PROPERTY OF FRONTLINE COMMUNICATIONS. IT IS CONFIDENTIAL AND ALL RIGHTS ARE RESERVED. IT SHALL NOT BE REPRODUCED, COPIED, LENT, OR USED FOR ANY PURPOSE OTHER THAN THAT FOR WHICH IT IS SPECIFICALLY FURNISHED.			<div><div><div>FRONTLINE</div><div>COMMUNICATIONS</div></div><div>12770 44th Street North Clearwater, FL 33762 Phone (727) 573-0400 www.frontlinecomm.com</div><div>An Oshkosh Corporation Company</div></div>			
PRELIMINARY USE ONLY THIS DRAWING IS FOR REPRESENTATION ONLY. DETAILED ENGINEERING DRAWINGS WILL BE CREATED FOR MANUFACTURING. CHANGES MAY BE REQUIRED TO ACCOMMODATE MANUFACTURING REQUIREMENTS AND CUSTOMER SPECIFICATIONS.			COBB COUNTY FIRE & EMERGENCY MCV - C-43X-4 - INTL 7600			
DRAWN	J.Chriss	DATE	8-5-16	SIZE	DWG NO.	REV
SHEET	3 OF 6	NOT TO SCALE	B	047422	-	

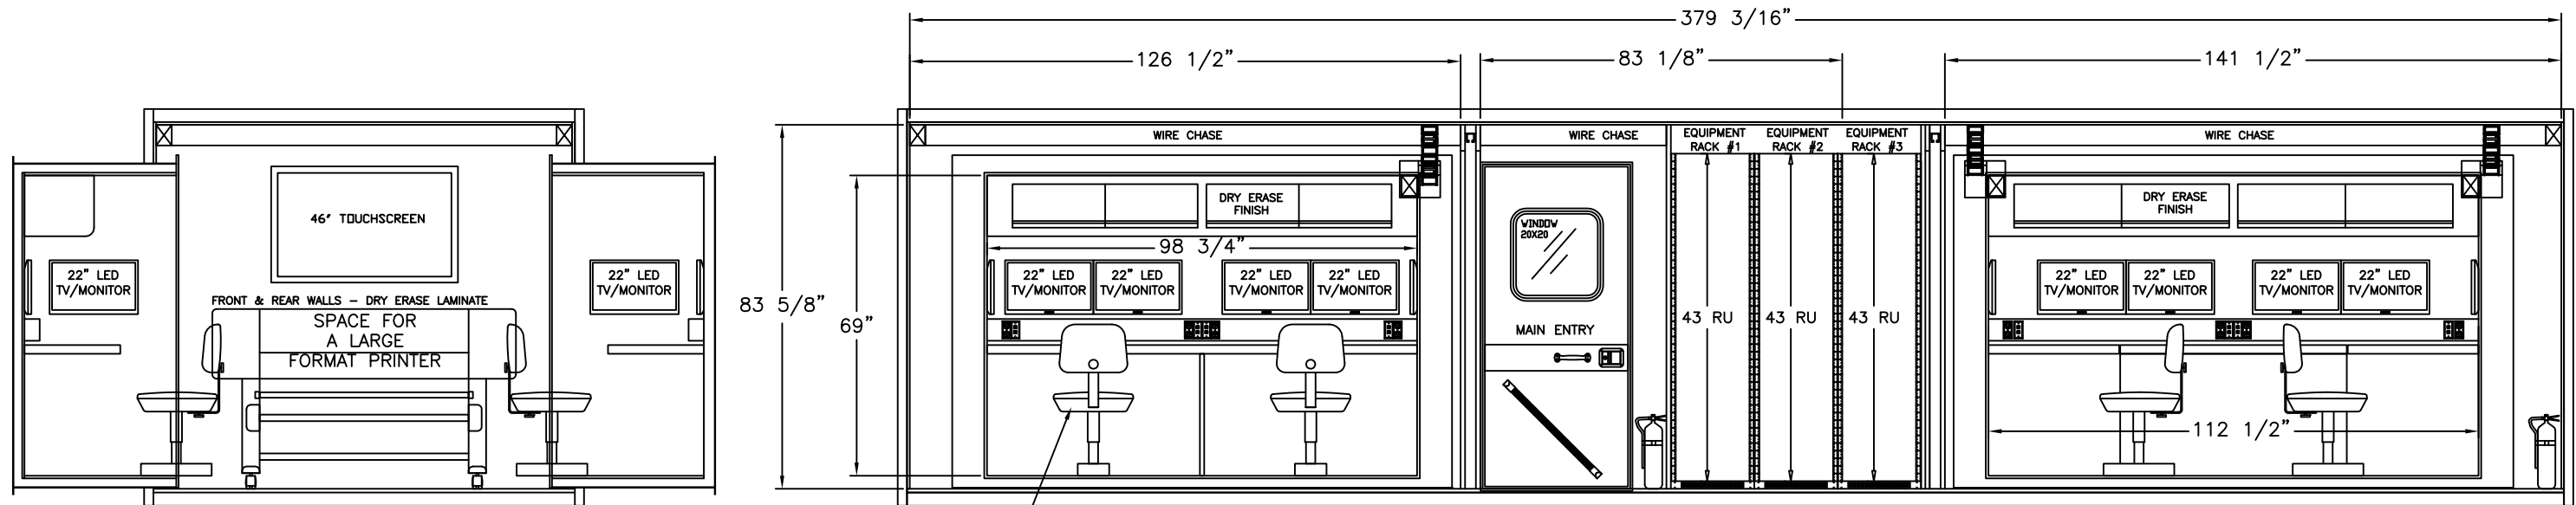

FRONT WALL

PEDESTAL MOUNTED CHAIRS  
AT EACH SLIDE-OUT WORKSTATION

CURB SIDE INTERIOR ELEVATION

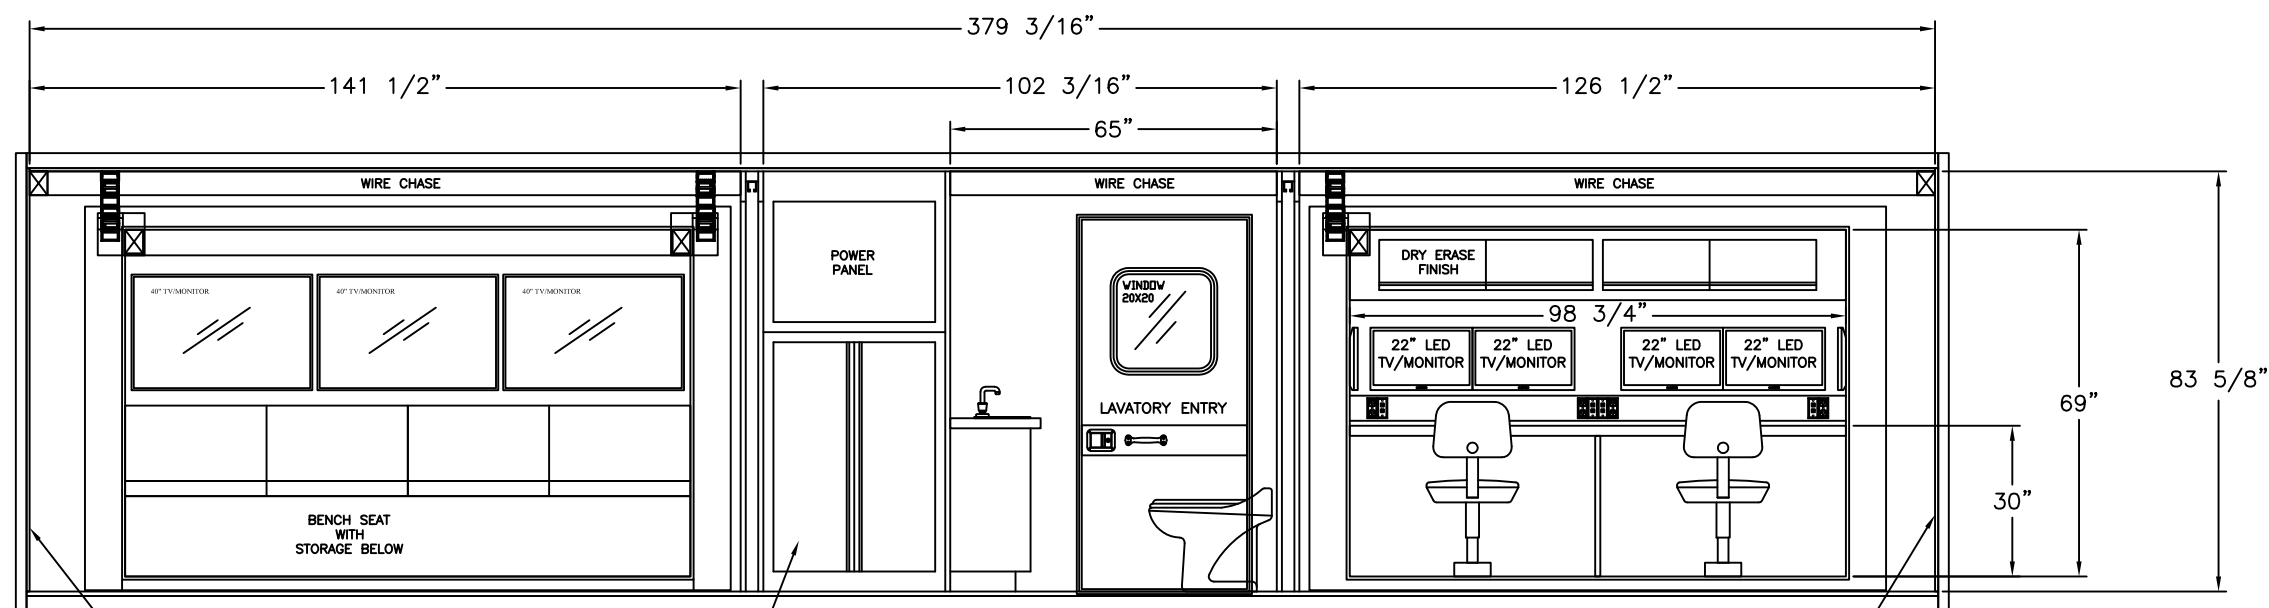

REAR WALL TO BE  
DRY ERASE LAMINATE

ADJUSTABLE SHELVES  
AND PRINTER AREA

FRONT WALL TO BE  
DRY ERASE LAMINATE

STREET SIDE INTERIOR ELEVATION

THIS DRAWING IS THE PROPERTY OF FRONTLINE COMMUNICATIONS. IT IS CONFIDENTIAL AND ALL RIGHTS ARE RESERVED. IT SHALL NOT BE REPRODUCED, COPIED, LENT, OR USED FOR ANY PURPOSE OTHER THAN THAT FOR WHICH IT IS SPECIFICALLY FURNISHED.


PRELIMINARY USE ONLY  
THIS DRAWING IS FOR REPRESENTATION ONLY. DETAILED ENGINEERING DRAWINGS WILL BE CREATED FOR MANUFACTURING. CHANGES MAY BE REQUIRED TO ACCOMMODATE MANUFACTURING REQUIREMENTS AND CUSTOMER SPECIFICATIONS.

DRAWN	J.Chriss	DATE	8-5-16
SHEET	4 OF 6	NOT TO SCALE	


**FRONTLINE COMMUNICATIONS**  
An Oshkosh Corporation Company  
12770 44th Street North  
Clearwater, FL 33762  
Phone (727) 573-0400  
www.frontlinecomm.com

**OSHKOSH**

<b>COBB COUNTY FIRE &amp; EMERGENCY</b>	
<b>MCV - C-43X-4 - INTL 7600</b>	
SIZE	DWG NO.
<b>B</b>	<b>047422</b>
REV	-

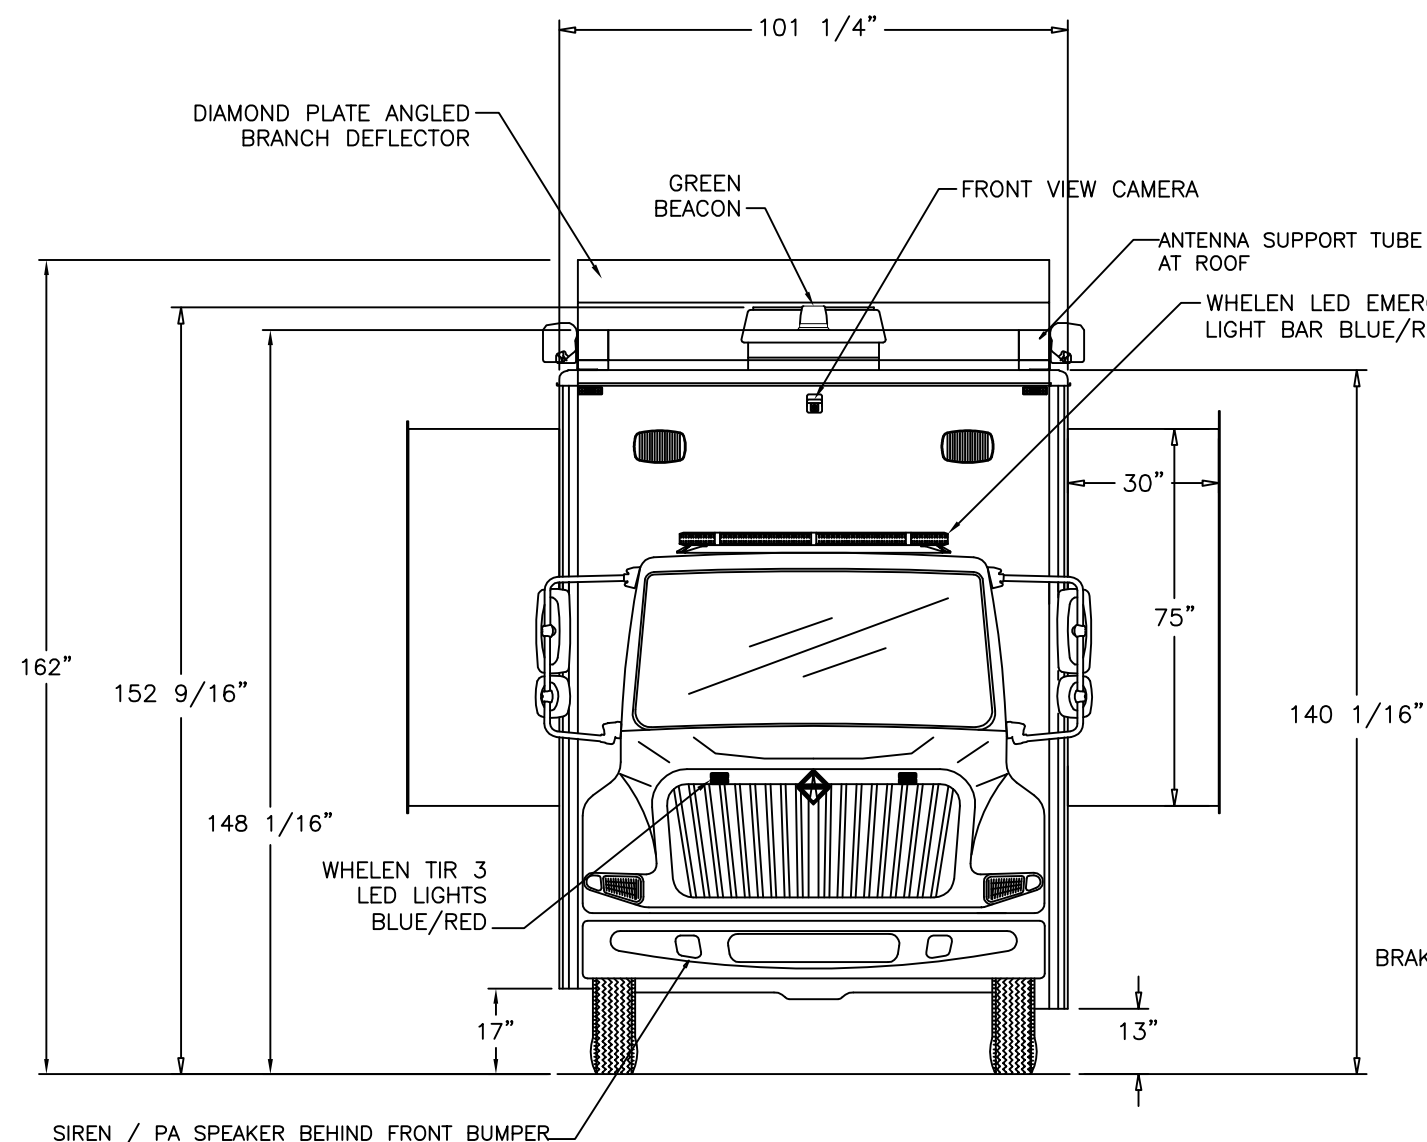


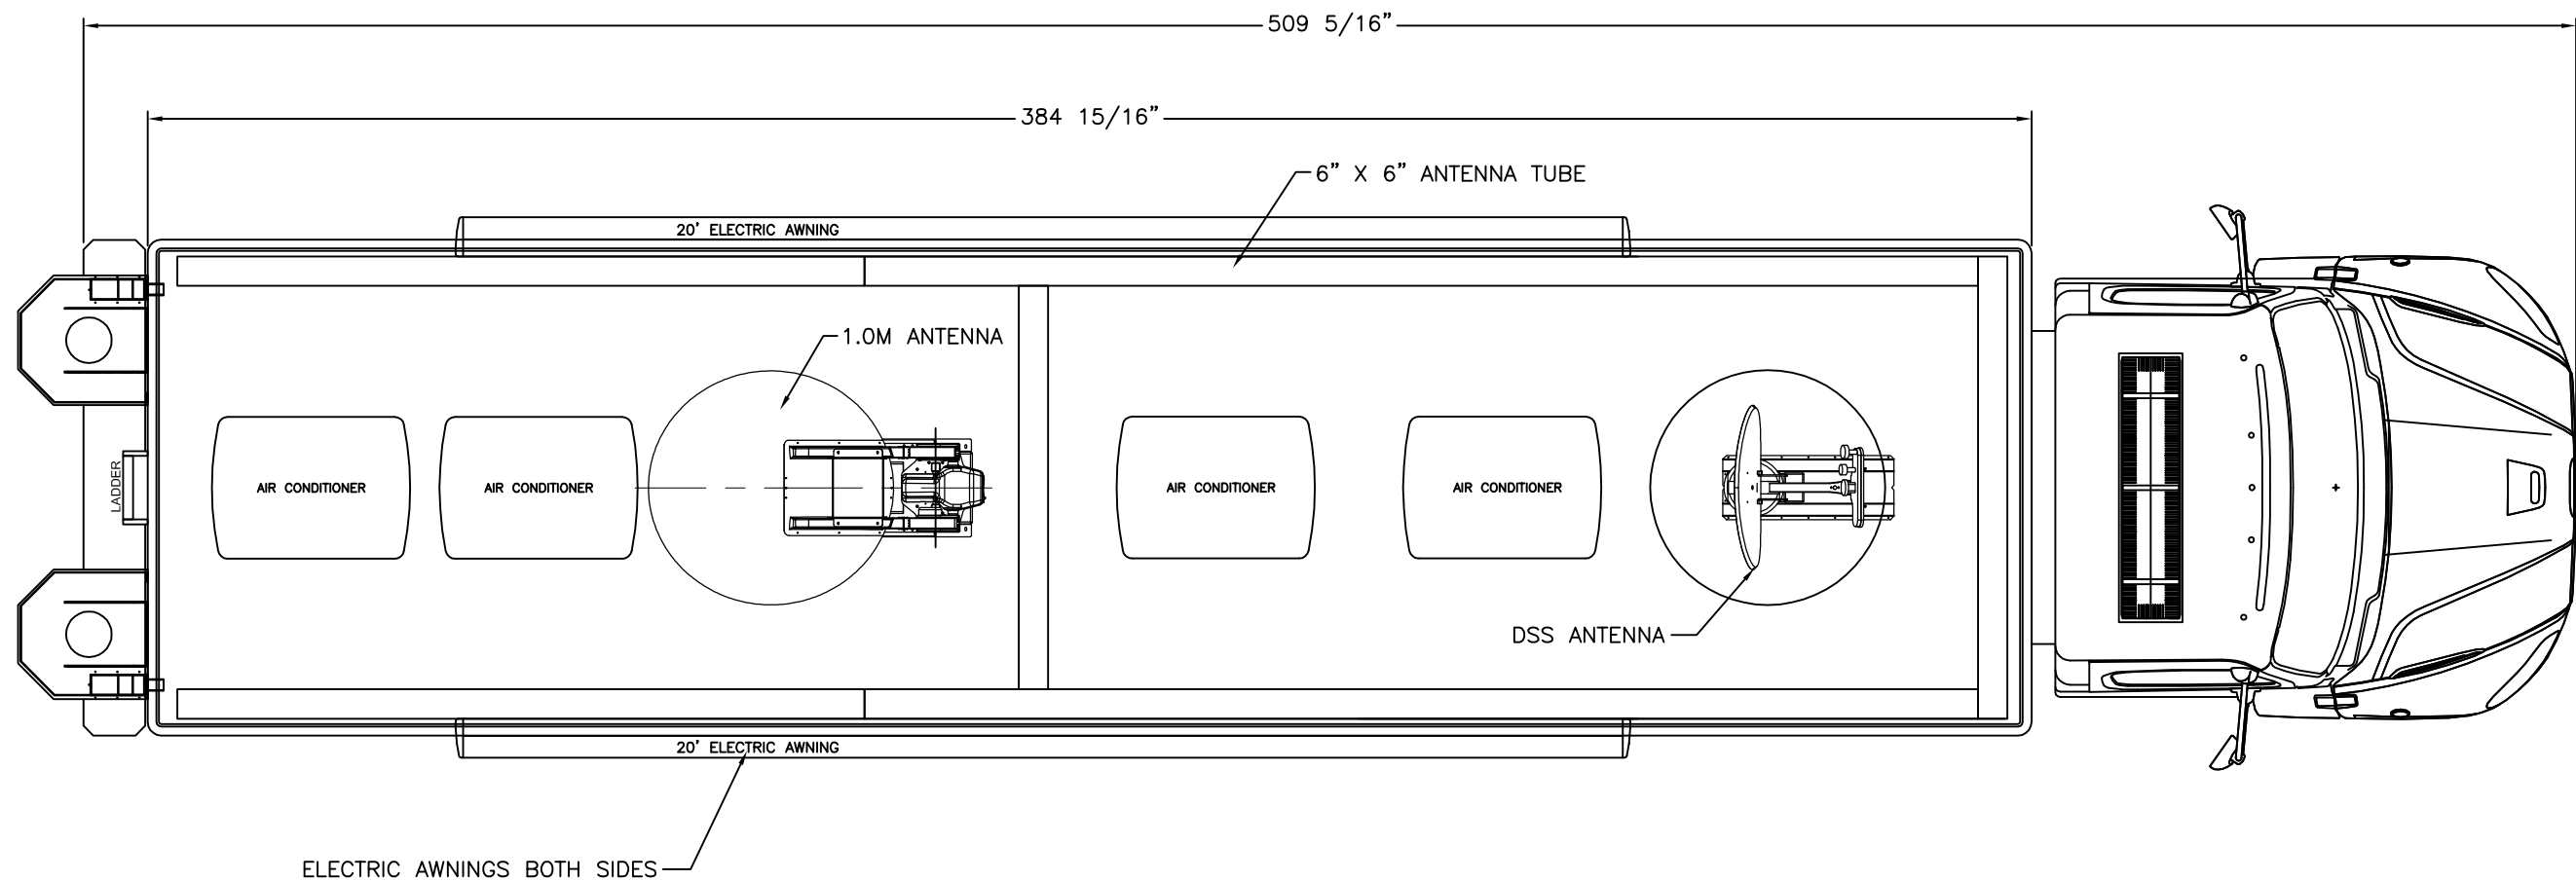
FRONT EXTERIOR

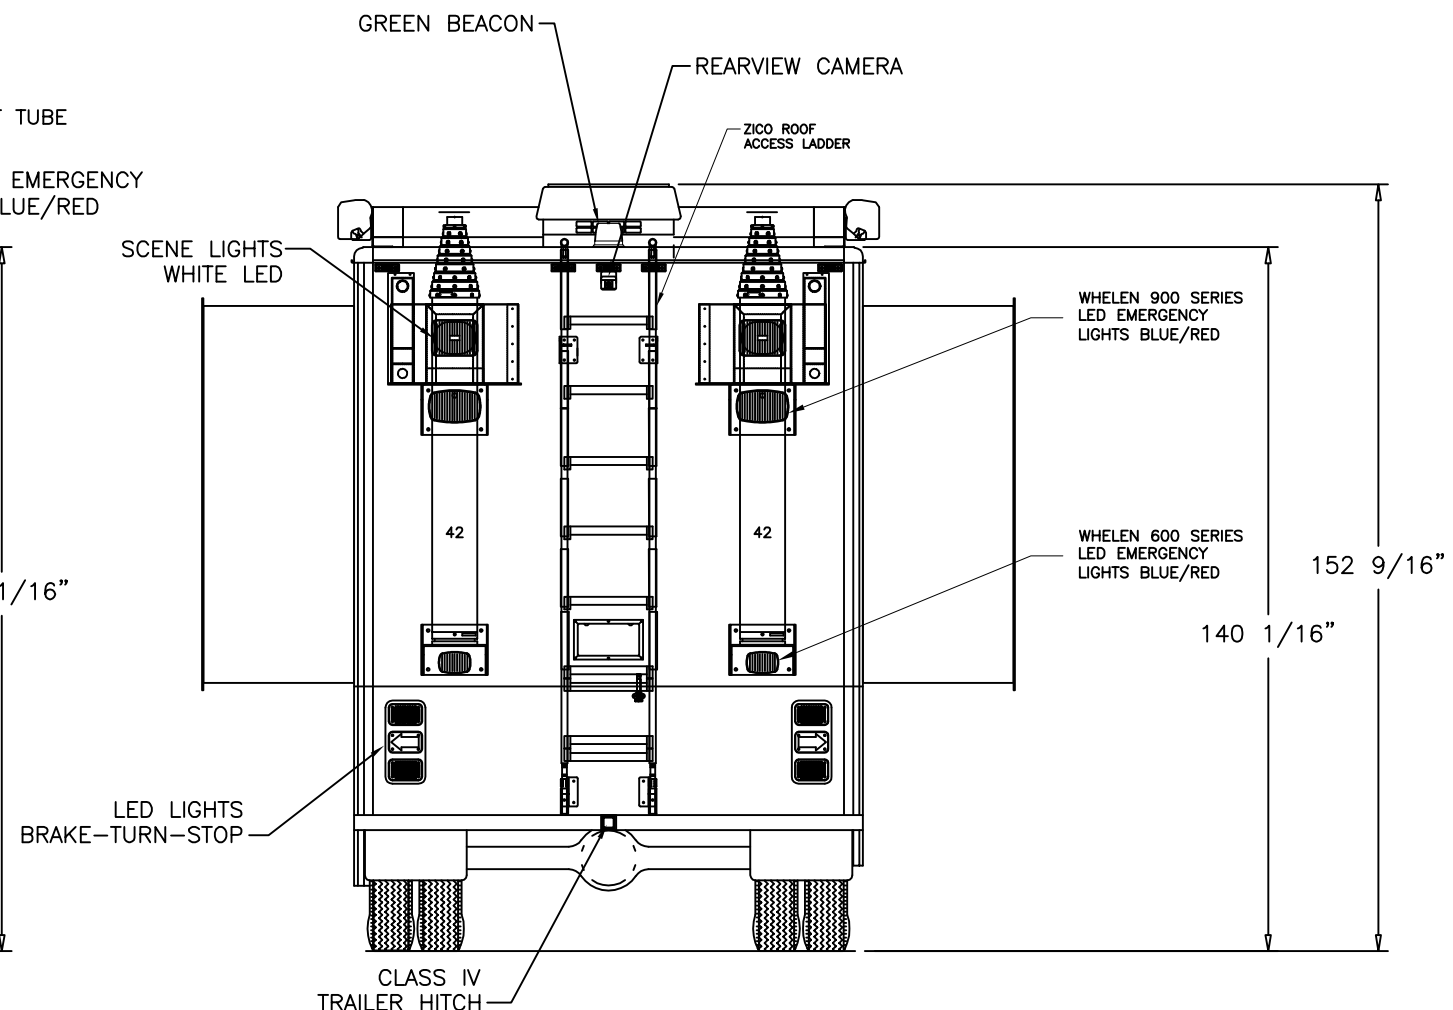

REAR ELEVATION

THIS DRAWING IS THE PROPERTY OF FRONTLINE COMMUNICATIONS. IT IS CONFIDENTIAL AND ALL RIGHTS ARE RESERVED. IT SHALL NOT BE REPRODUCED, COPIED, LENT, OR USED FOR ANY PURPOSE OTHER THAN THAT FOR WHICH IT IS SPECIFICALLY FURNISHED.	
PRELIMINARY USE ONLY THIS DRAWING IS FOR REPRESENTATION ONLY. DETAILED ENGINEERING DRAWINGS WILL BE CREATED FOR MANUFACTURING. CHANGES MAY BE REQUIRED TO ACCOMMODATE MANUFACTURING REQUIREMENTS AND CUSTOMER SPECIFICATIONS.	
DRAWN J.Chriss	DATE 8-5-16
SHEET 5 OF 6	NOT TO SCALE

 An Oshkosh Corporation Company		12770 44th Street North Clearwater, FL 33762 Phone (727) 573-0400 www.frontlinecomm.com			
COBB COUNTY FIRE & EMERGENCY MCV - C-43X-4 - INTL 7600					
SIZE B		DWG NO. 047422		REV -	



THIS DRAWING IS THE PROPERTY OF FRONTLINE COMMUNICATIONS. IT IS CONFIDENTIAL AND ALL RIGHTS ARE RESERVED. IT SHALL NOT BE REPRODUCED, COPIED, LENT, OR USED FOR ANY PURPOSE OTHER THAN THAT FOR WHICH IT IS SPECIFICALLY FURNISHED.

PRELIMINARY USE ONLY  
THIS DRAWING IS FOR REPRESENTATION ONLY. DETAILED ENGINEERING DRAWINGS WILL BE CREATED FOR MANUFACTURING. CHANGES MAY BE REQUIRED TO ACCOMMODATE MANUFACTURING REQUIREMENTS AND CUSTOMER SPECIFICATIONS.

DRAWN	J.Chriss	DATE	8-5-16
SHEET	6 OF 6	NOT TO SCALE	

**FRONTLINE**  
COMMUNICATIONS

12770 44th Street North  
Clearwater, FL 33762  
Phone (727) 573-0400  
www.frontlinecomm.com

**OSHKOSH**

An Oshkosh Corporation Company

**COBB COUNTY  
FIRE & EMERGENCY  
MCV - C-43X-4 - INTL 7600**

SIZE	DWG NO.	REV
B	047422	-